

LEGEND

	SANITARY SEWER MAIN
	WATER MAIN
	STORM DRAIN LINE
	WATER VALVE
	FIRE HYDRANT
	CATCH BASIN, TYPE 1
	SANITARY SEWER MANHOLE
	SIDEWALK
	ASPHALT
	CRITICAL AREA BUFFER
	WETLAND

NOTES:
 1. SEE ROAD AND UTILITY PLANS FOR STREET CROSS SECTIONS.

REVISIONS		
NO.	DESCRIPTION/DATE	BY



ESM CONSULTING ENGINEERS, LLC
 2500 Bay Ave, Ste 205
 Federal Way, WA 98003
 (206) 838-6113
 (206) 397-9900
 www.esmcivil.com
 Land Surveying | Land Planning | Landscape Architecture
 Project Management | Public Works

MONTEBANC MANAGEMENT, LLC
PINNACLE AT LIBERTY BAY SUBDIVISION
 OVERALL INFRASTRUCTURE PLAN
 WASHINGTON
 CITY OF POULSBORO

JOB NO.:	2090-004-022
DWG. NAME:	PP-15
DESIGNED BY:	
DRAWN BY:	
CHECKED BY:	
DATE:	04/09/2026
DATE OF PRINT:	


File: \\sm8\ENGR\ESM-0085\2090\004\022\PP-15.dwg
 Plotted: 4/10/2026 12:18 PM
 Plotted By: Corrie Barrett

A PORTION OF THE SE 1/4 OF SECTION 23, TWP. 26 N., RGE. 1 E., WM

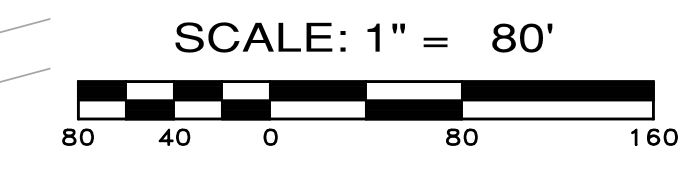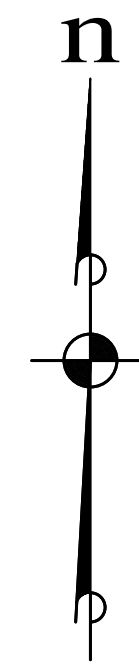

LEGEND

- SANITARY SEWER MAIN
- WATER MAIN
- STORM DRAIN LINE
- FIRE HYDRANT
- CATCH BASIN, TYPE 1
- SANITARY SEWER MANHOLE
- - - 200 EXISTING CONTOURS
- - - 200 PROPOSED CONTOURS
- ▨ CRITICAL AREA BUFFER
- ▨ WETLAND
- ▨ INFRASTRUCTURE PHASE 1

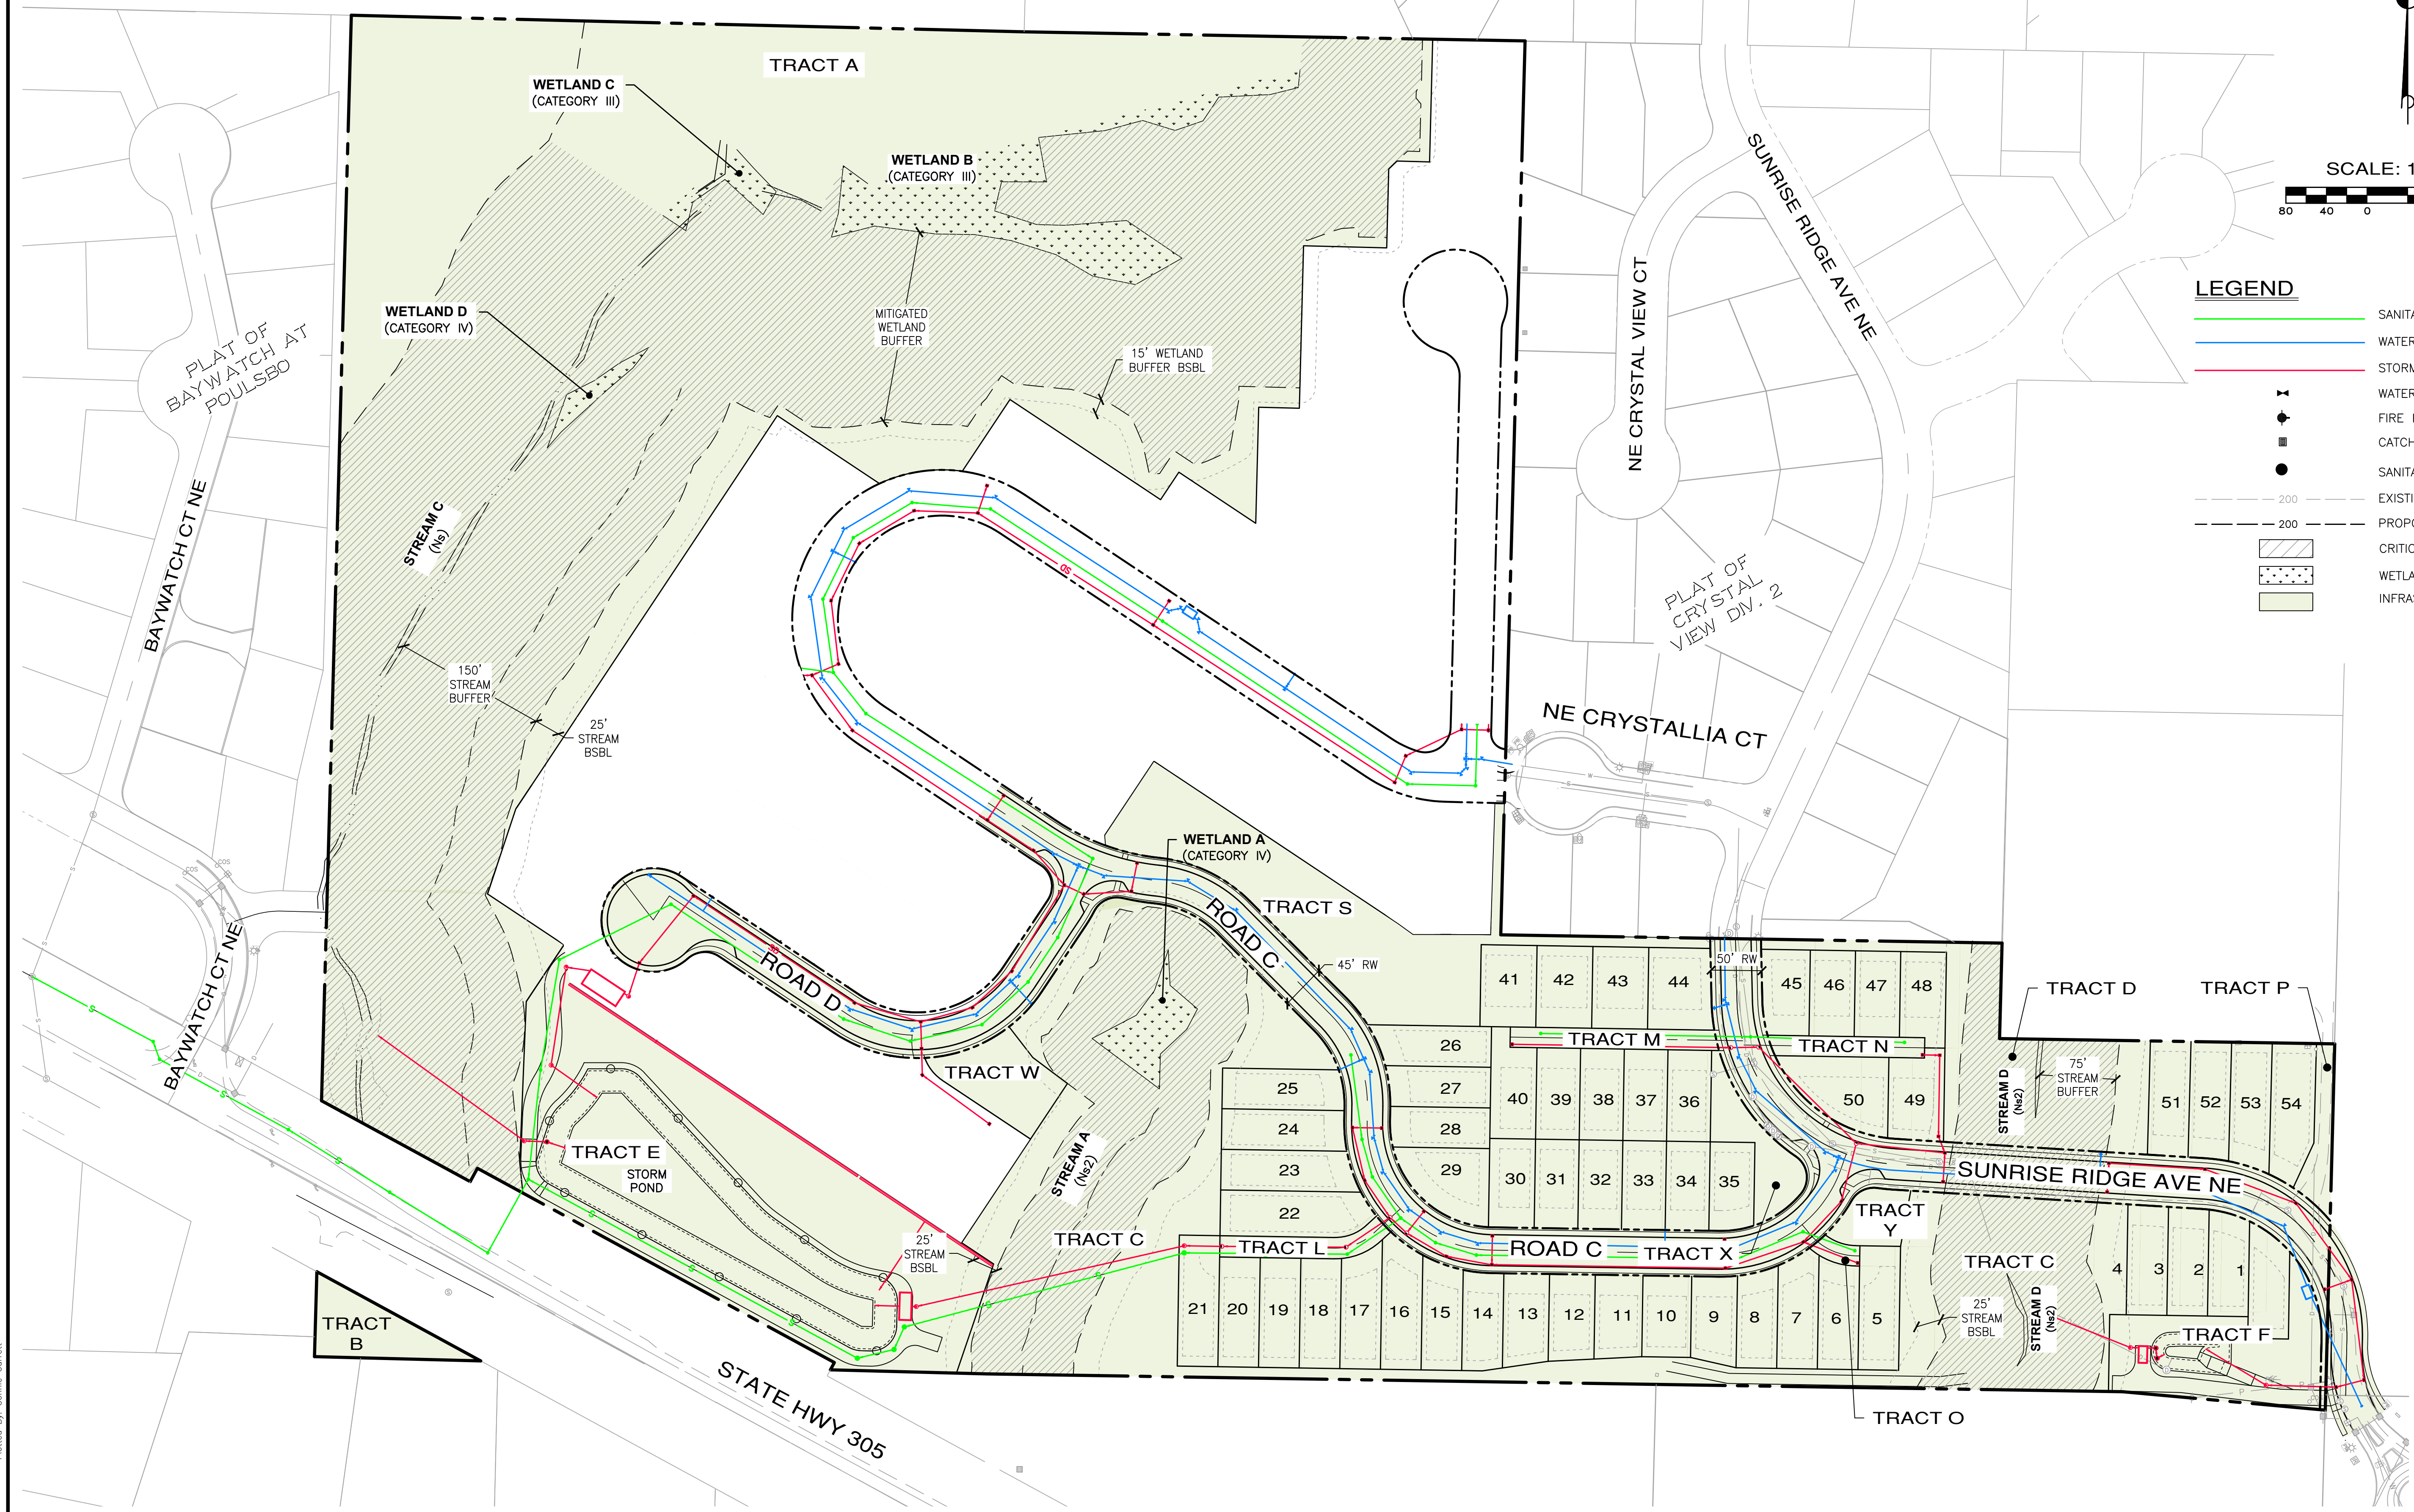

REVISIONS		
NO.	DESCRIPTION/DATE	BY



ESM CONSULTING ENGINEERS, LLC
 2000 Bayview Street, Suite 505
 Federal Way, WA 98003
 FEDERAL WAY (253) 838-6113
 LYNNWOOD (425) 397-9900
 www.esmcivil.com
 Civil Engineering | Land Surveying | Project Management | Landscape Architecture

MONTEBANC MANAGEMENT, LLC
PINNACLE AT LIBERTY BAY SUBDIVISION
 INFRASTRUCTURE PLAN - PHASE 1
 CITY OF POULSBORO WASHINGTON


 
 






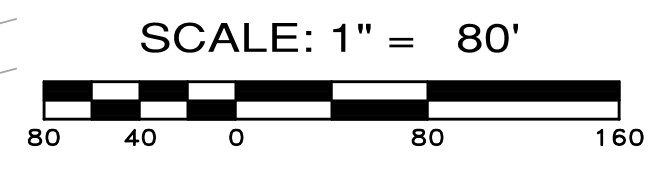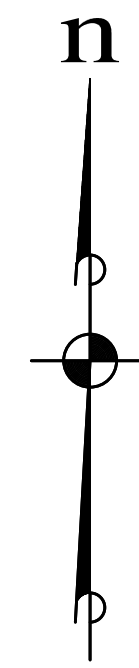

 
JOB NO.:	2090-004-022
DWG. NAME:	PP-16
DESIGNED BY:	
DRAWN BY:	
CHECKED BY:	
DATE:	04/09/2026
DATE OF PRINT:	


File: \\mm8\ENGR\ESM\0090\004\022\PP-16.dwg
 Plotted: 4/10/2026 11:28 AM
 Plotted By: Corrie Barrett

A PORTION OF THE SE 1/4 OF SECTION 23, TWP. 26 N., RGE. 1 E., WM



LEGEND

-  SANITARY SEWER MAIN
-  WATER MAIN
-  STORM DRAIN LINE
-  WATER VALVE
-  FIRE HYDRANT
-  CATCH BASIN, TYPE 1
-  SANITARY SEWER MANHOLE
-  EXISTING CONTOURS
-  PROPOSED CONTOURS
-  CRITICAL AREA BUFFER
-  WETLAND
-  INFRASTRUCTURE PHASE 2

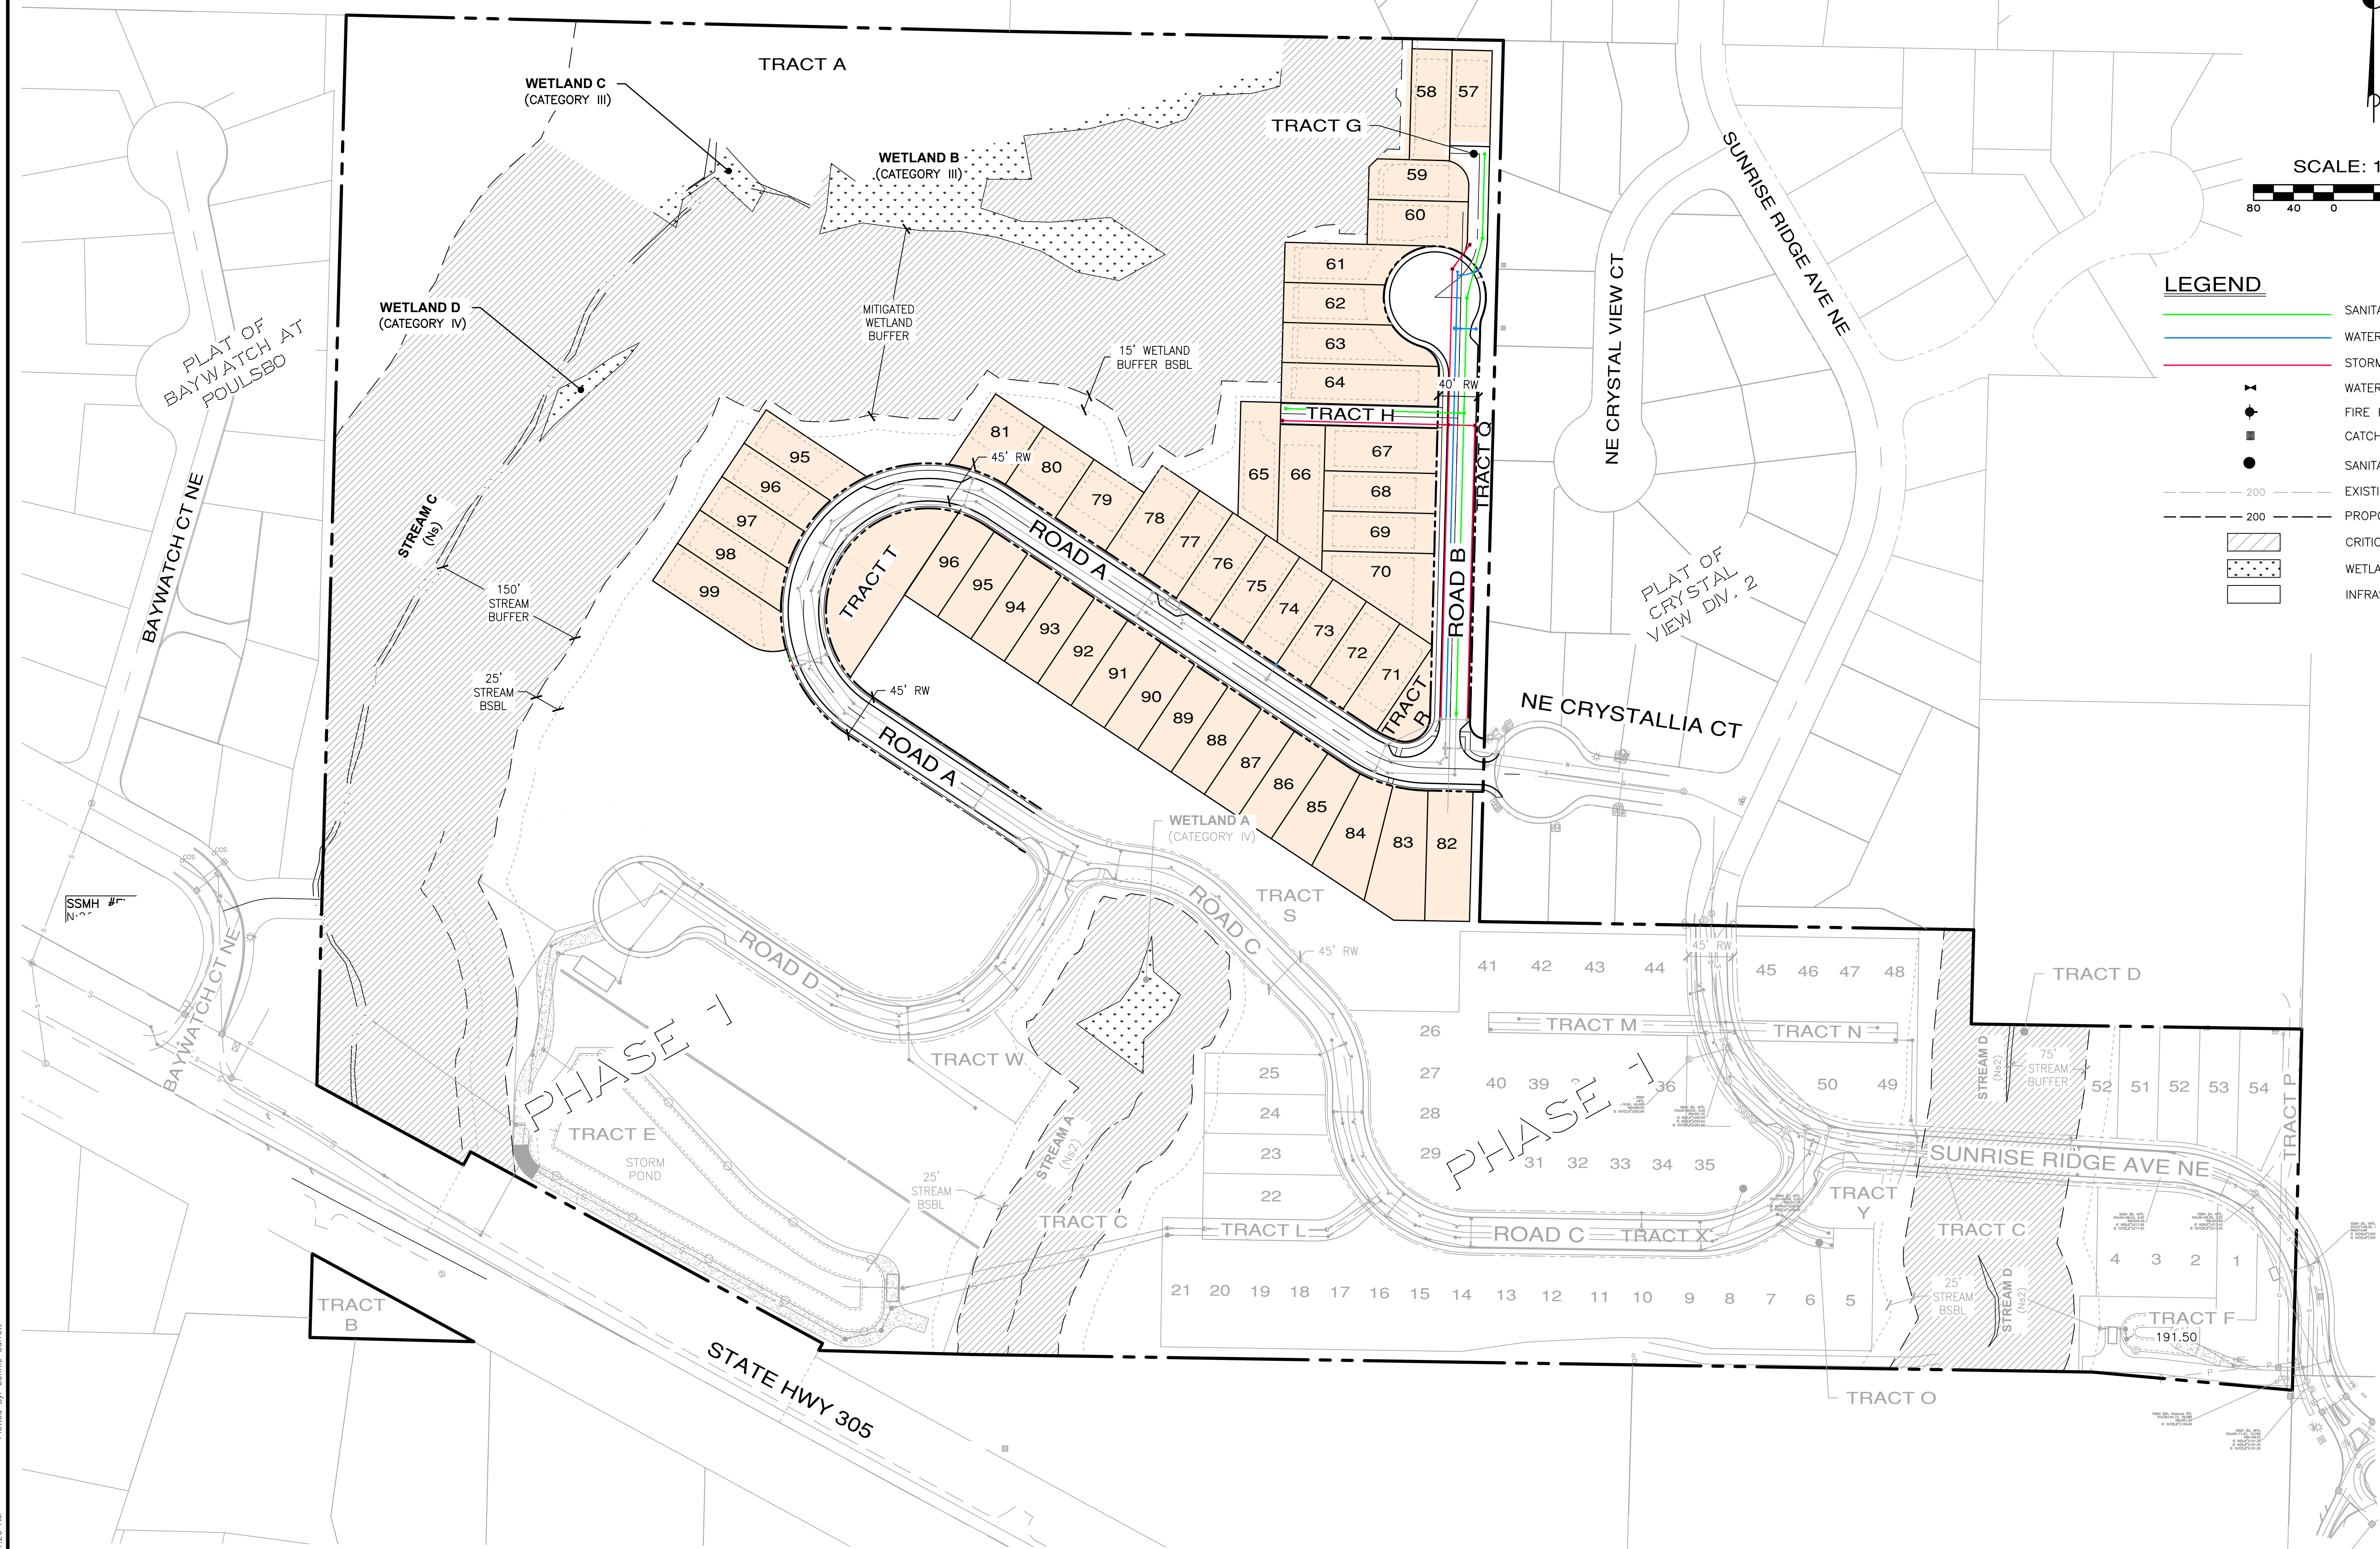

REVISIONS		
NO.	DESCRIPTION/DATE	BY





ESM CONSULTING ENGINEERS, LLC
 2500 Bay Ave, Suite 505
 Federal Way, WA 98003
 (253) 838-6113
 (253) 397-9900
 www.esmcivil.com
 Civil Engineering | Land Surveying | Project Management | Landscape Architecture
 Public Works | Infrastructure

MONTEBANC MANAGEMENT, LLC
PINNACLE AT LIBERTY BAY SUBDIVISION
 INFRASTRUCTURE PLAN - PHASE 2
 CITY OF POULSBORO WASHINGTON


 
 





 

 
JOB NO.:	2090-004-022
DWG. NAME:	PP-17
DESIGNED BY:	
DRAWN BY:	
CHECKED BY:	
DATE:	04/09/2026
DATE OF PRINT:	

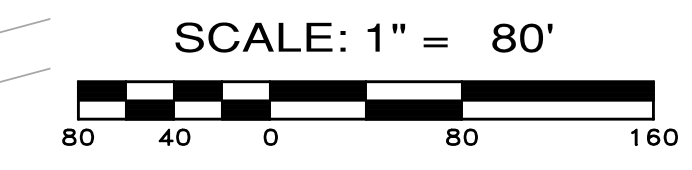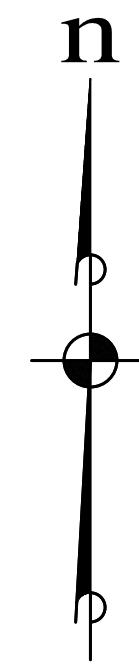File: \\mm8\ENGR\ESM-0085\2090\004\022\PP-plan\liba\PP-17.dwg
 Plotted: 4/10/2026 11:26 AM
 Plotted By: Corrie Barrett

A PORTION OF THE SE 1/4 OF SECTION 23, TWP. 26 N., RGE. 1 E., WM



LEGEND

-  SANITARY SEWER MAIN
-  WATER MAIN
-  STORM DRAIN LINE
-  FIRE HYDRANT
-  CATCH BASIN, TYPE 1
-  SANITARY SEWER MANHOLE
-  EXISTING CONTOURS
-  PROPOSED CONTOURS
-  CRITICAL AREA BUFFER
-  WETLAND
-  INFRASTRUCTURE PHASE 3



REVISIONS		
NO.	DESCRIPTION/DATE	BY

ESM CONSULTING ENGINEERS, LLC
 5000 1st Ave S, Ste 505
 Federal Way, WA 98003
 FEDERAL WAY
 LYNNWOOD
 (253) 838-6113
 (425) 397-9900
 www.esmcivil.com
 Civil Engineering | Land Surveying | Project Management | Landscape Architecture
 Public Works | Infrastructure

MONTEBANC MANAGEMENT, LLC
PINNACLE AT LIBERTY BAY SUBDIVISION
 INFRASTRUCTURE PLAN - PHASE 3
 CITY OF POULSBORO WASHINGTON

JOB NO.:	2090-004-022
DWG. NAME:	PP-18
DESIGNED BY:	
DRAWN BY:	
CHECKED BY:	
DATE:	04/09/2026
DATE OF PRINT:	

File: \\smm\ENGR\ESM-JOB\2090\004\022\PP-18.dwg
 Plotted: 4/10/2026 11:34 AM
 Plotted By: Corrie Corrett